


Project 1 Con 263

First Floor Plan

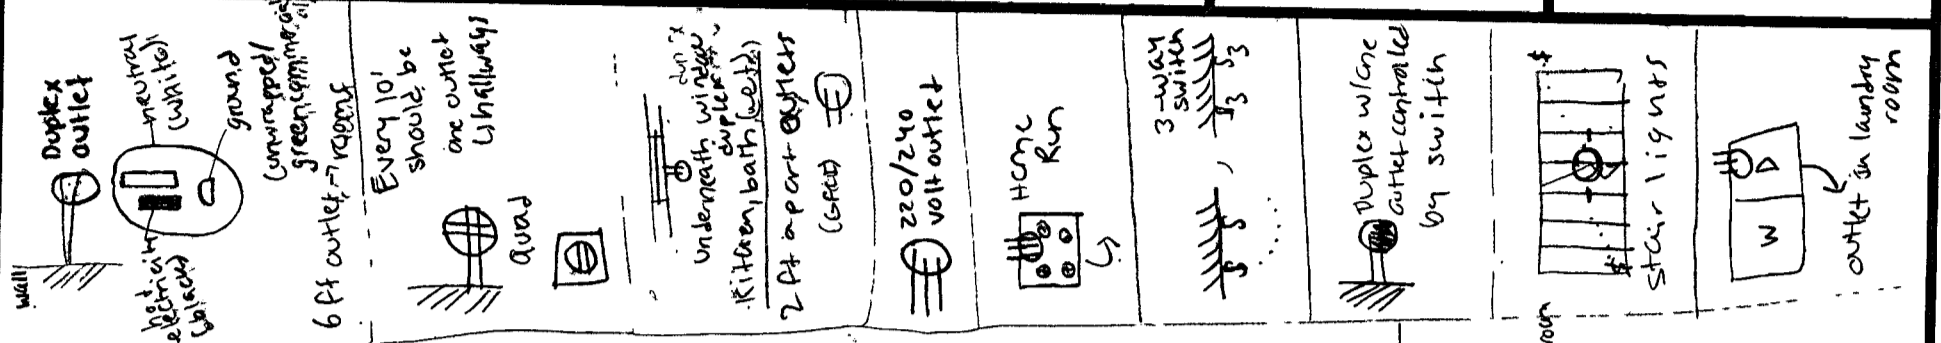


only if there is a burning appliance

Smoke detectors  
 1) sleeping rooms  
 2) immediate area outside sleeping area  
 3) at each bathroom

Carbon monoxide detector:  
 1) sleeping room  
 2) immediate area outside sleeping area  
 3) at each bathroom


Symbol

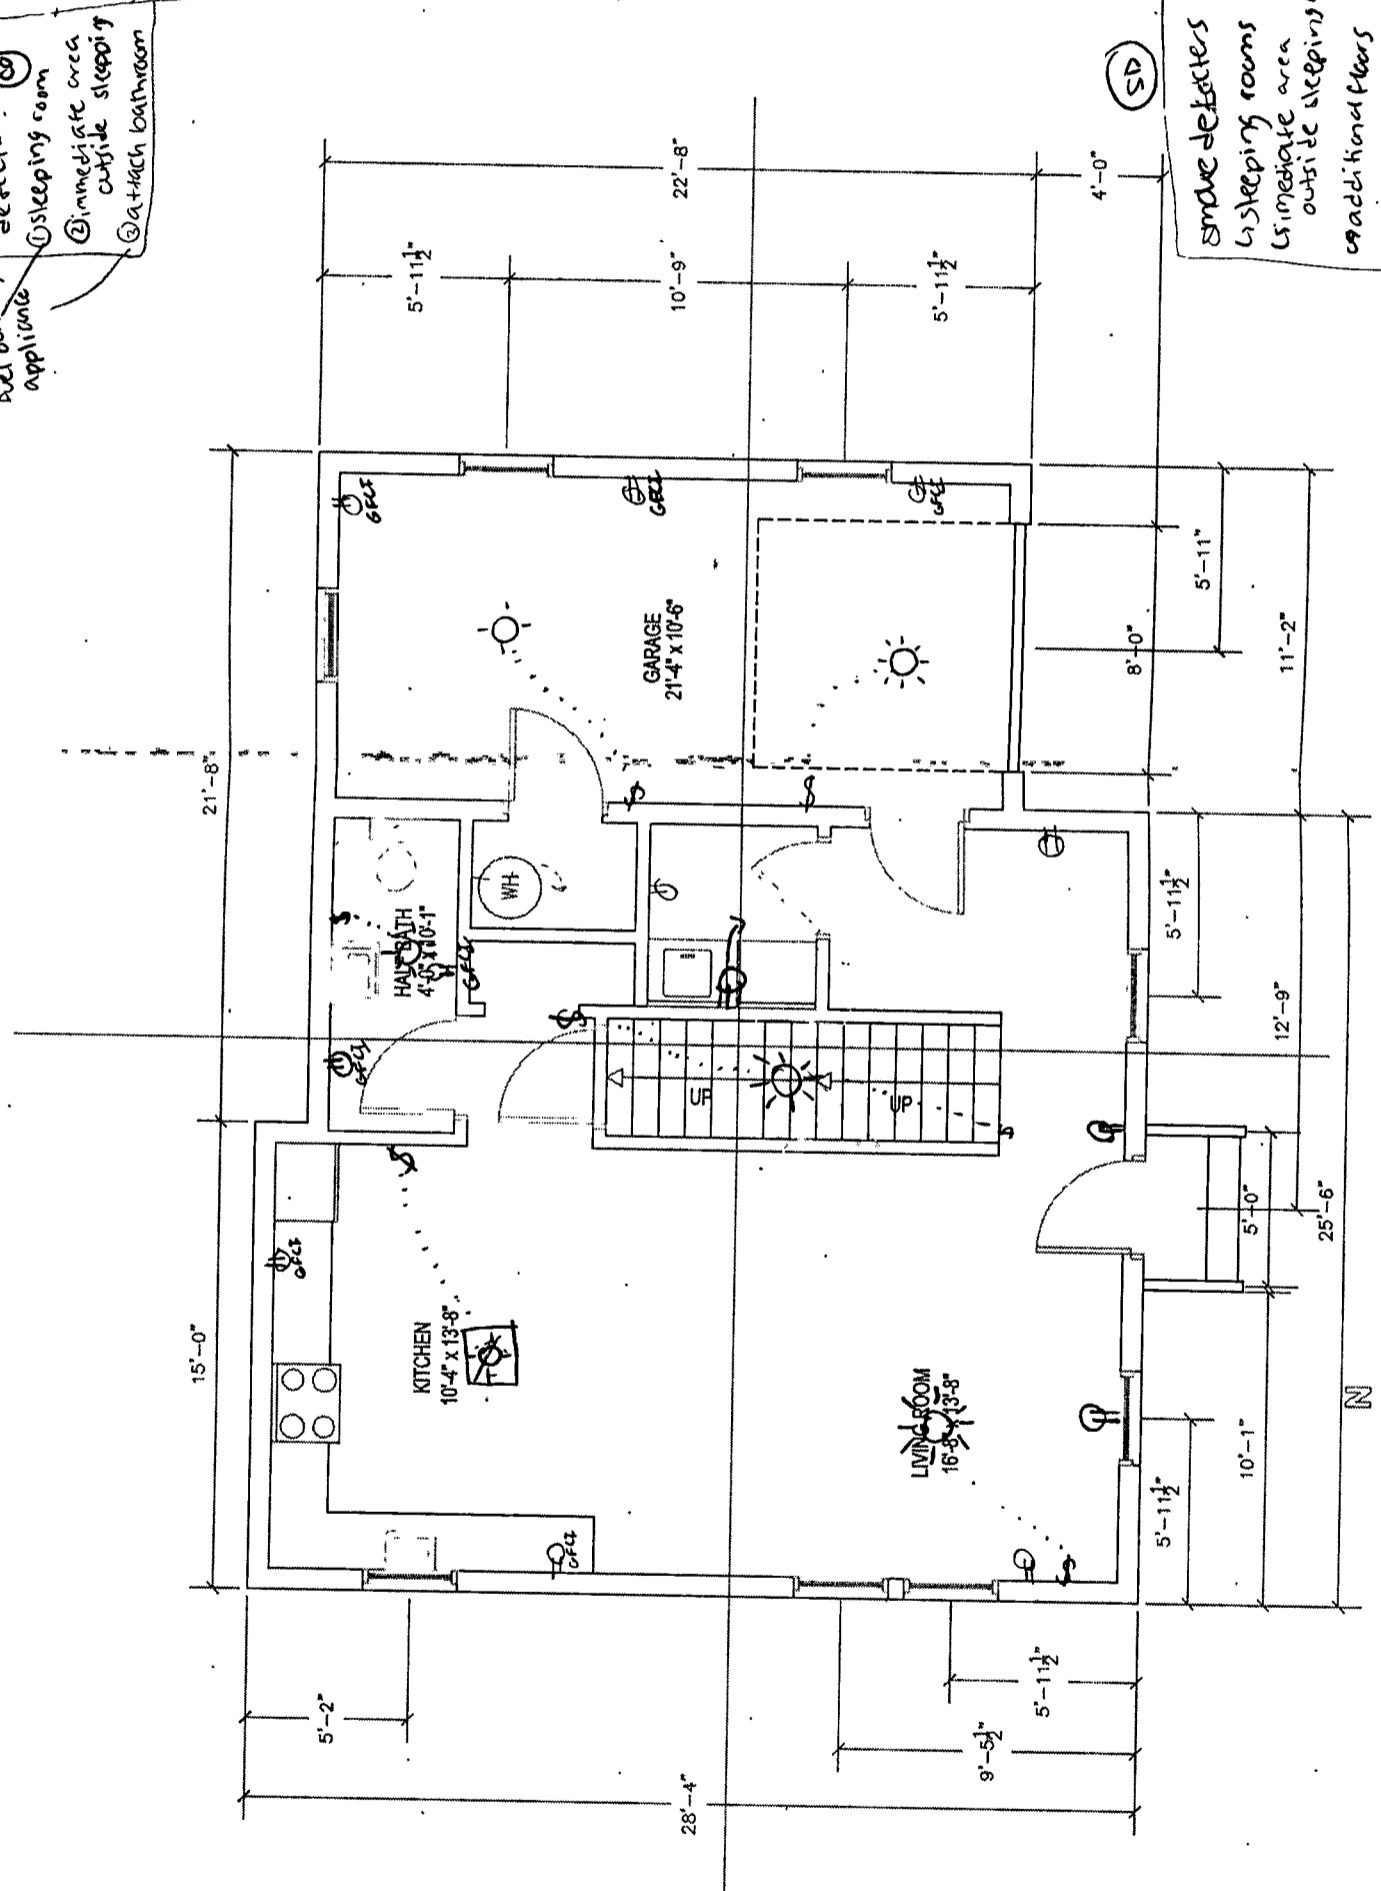


FIRST FLOOR PLAN  
SCALE 1/8" = 1'-0"


\*Side note  
 Open Autocad -> connect browser  
 -> tool palette -> imperial -> electric  
 (symbols for duplex outlet)


Second Floor Plan  
Project 1 Con 263

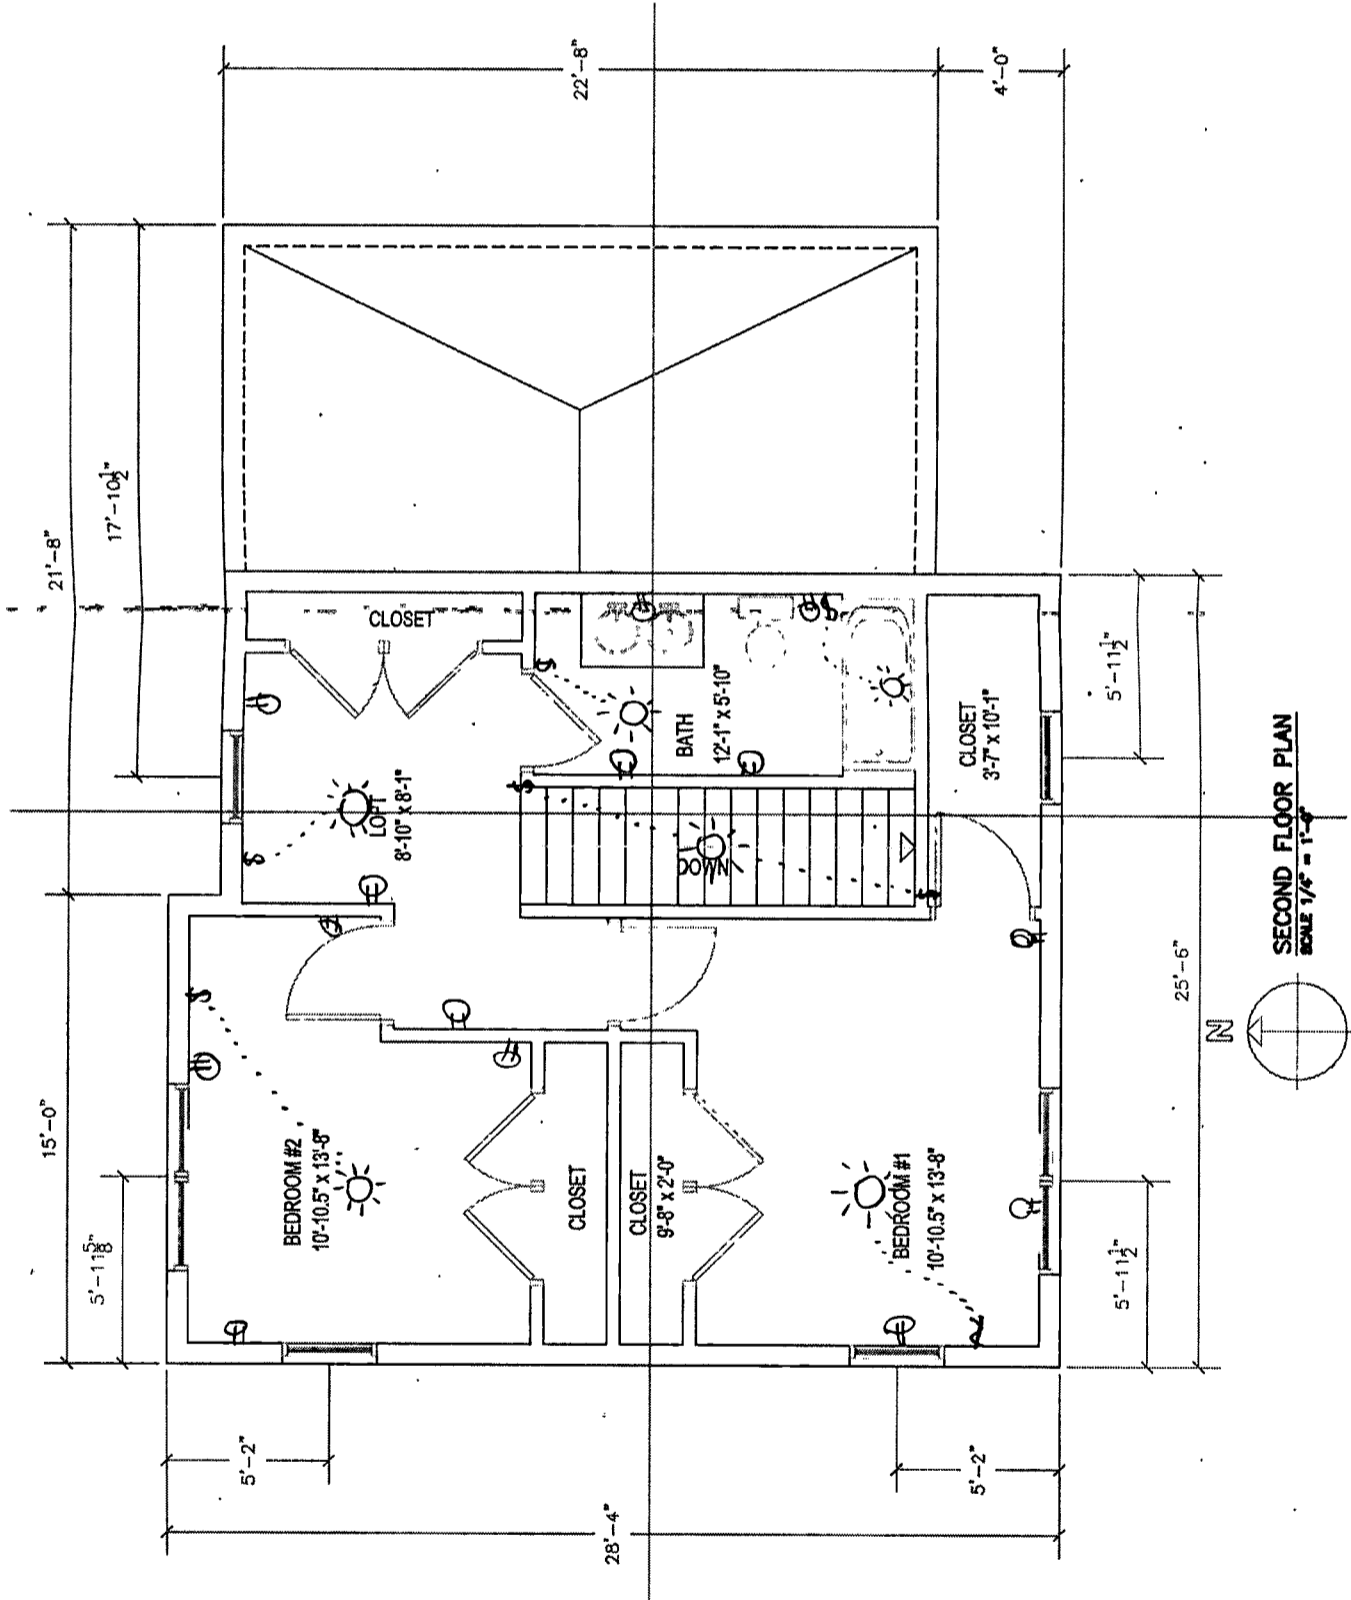

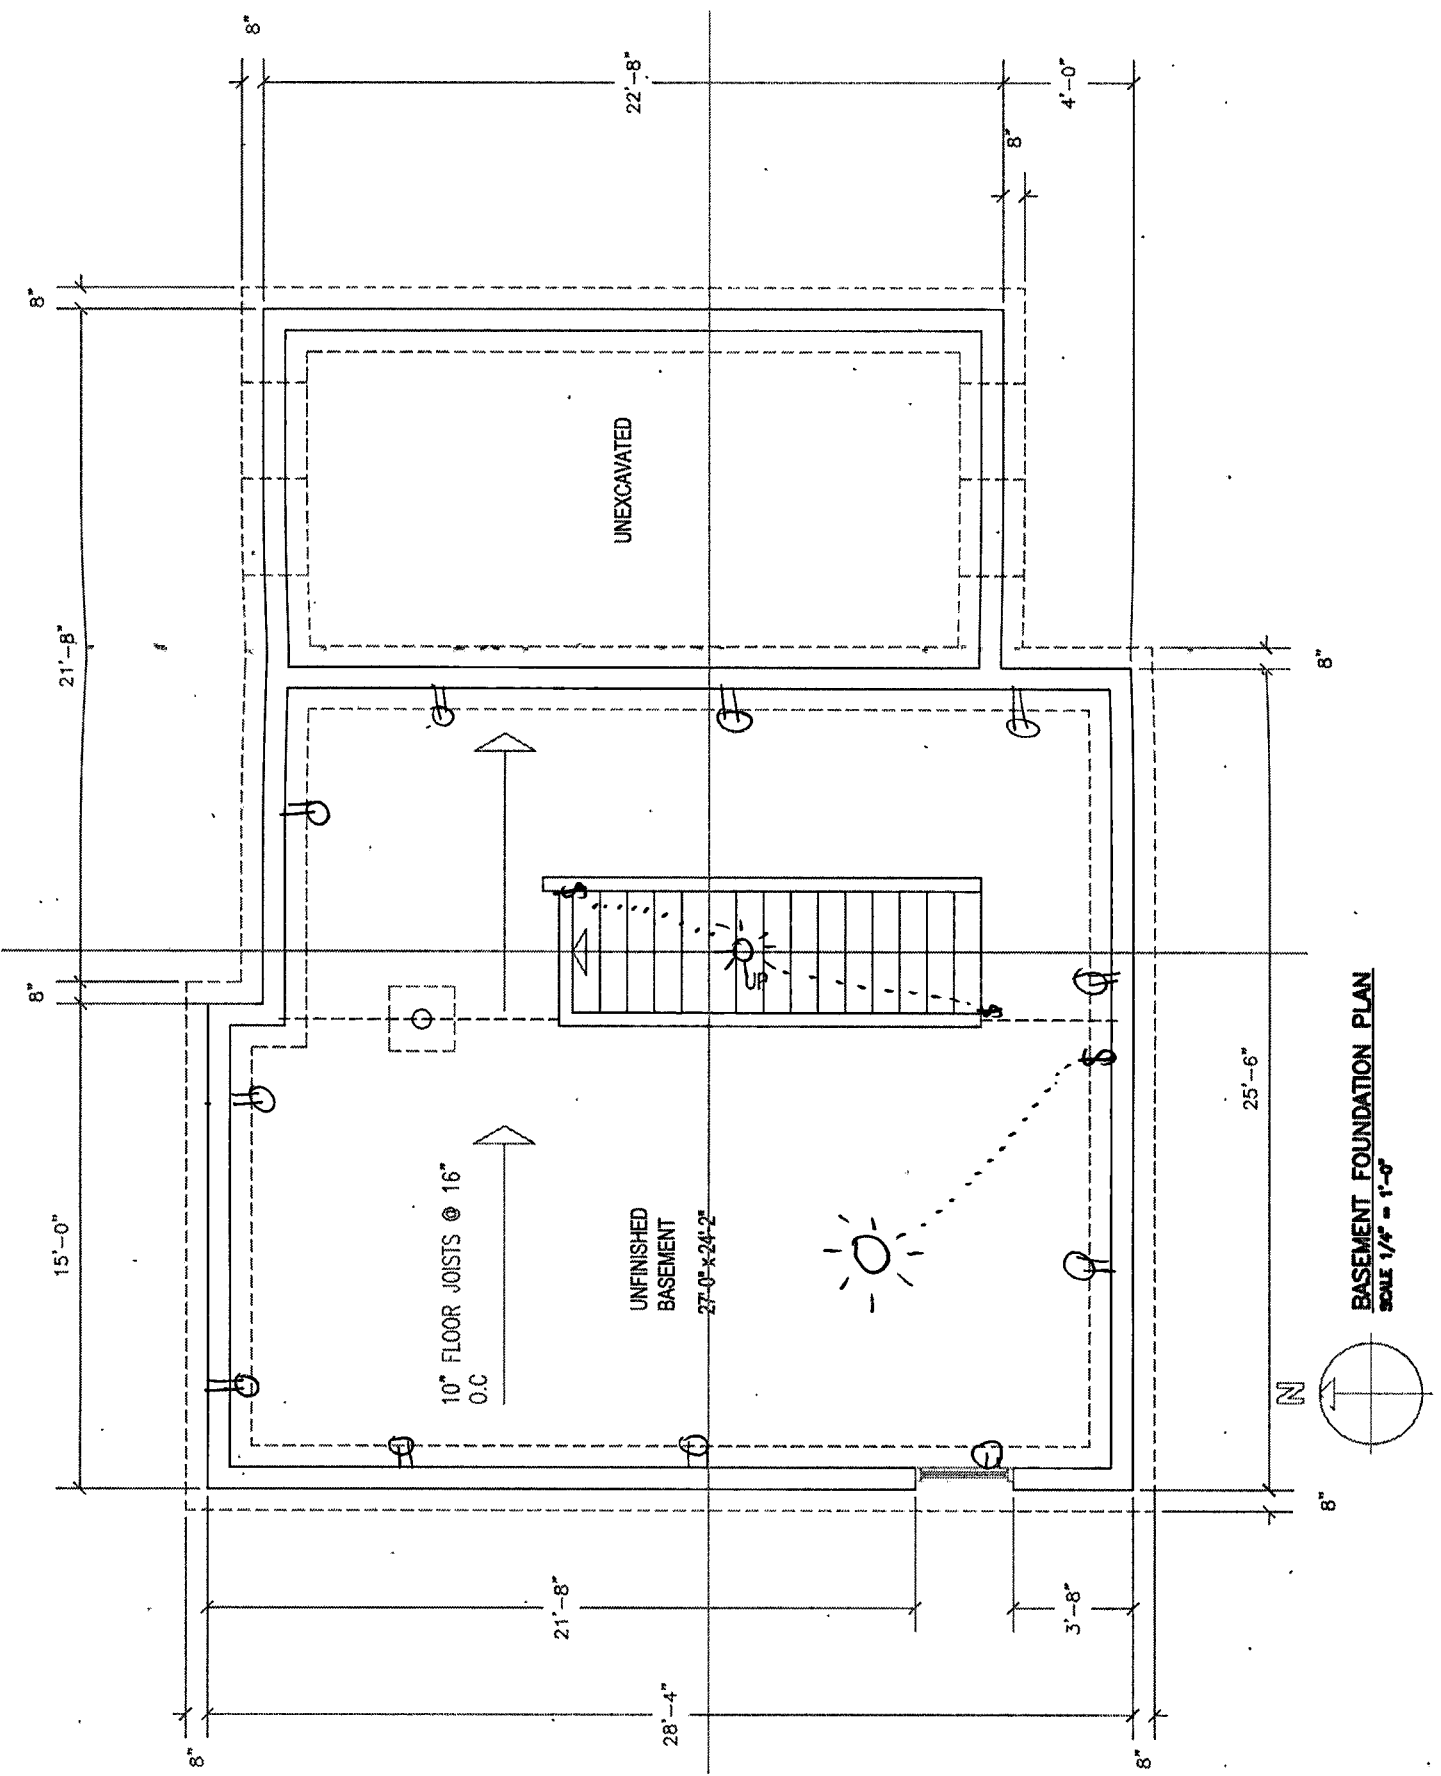

 BASEMENT FOUNDATION PLAN  
SCALE 1/4" = 1'-0"

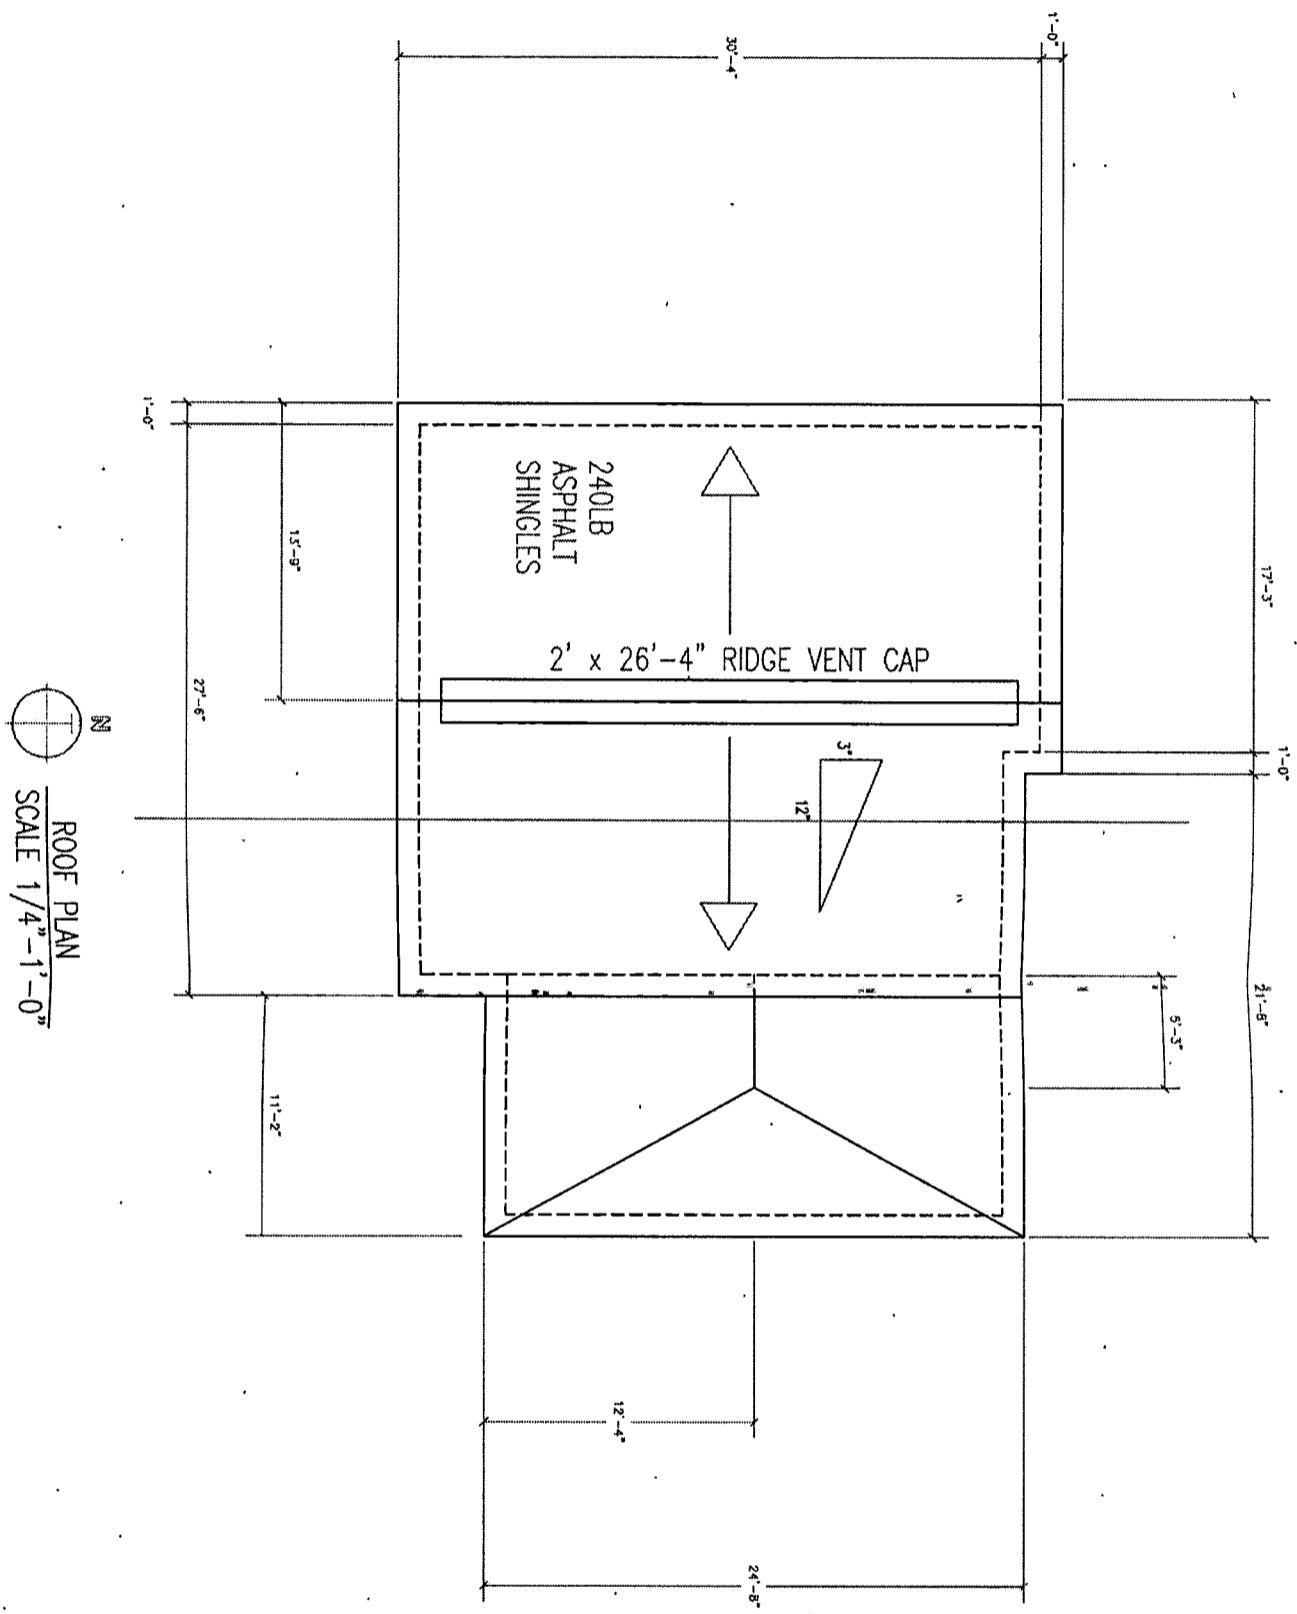

 N  
 ROOF PLAN  
 SCALE 1/4" = 1'-0"

Roof Plan

Project 1 Con 263

REFERENCE.DWG

Farheen Hyder  
2/20/18